

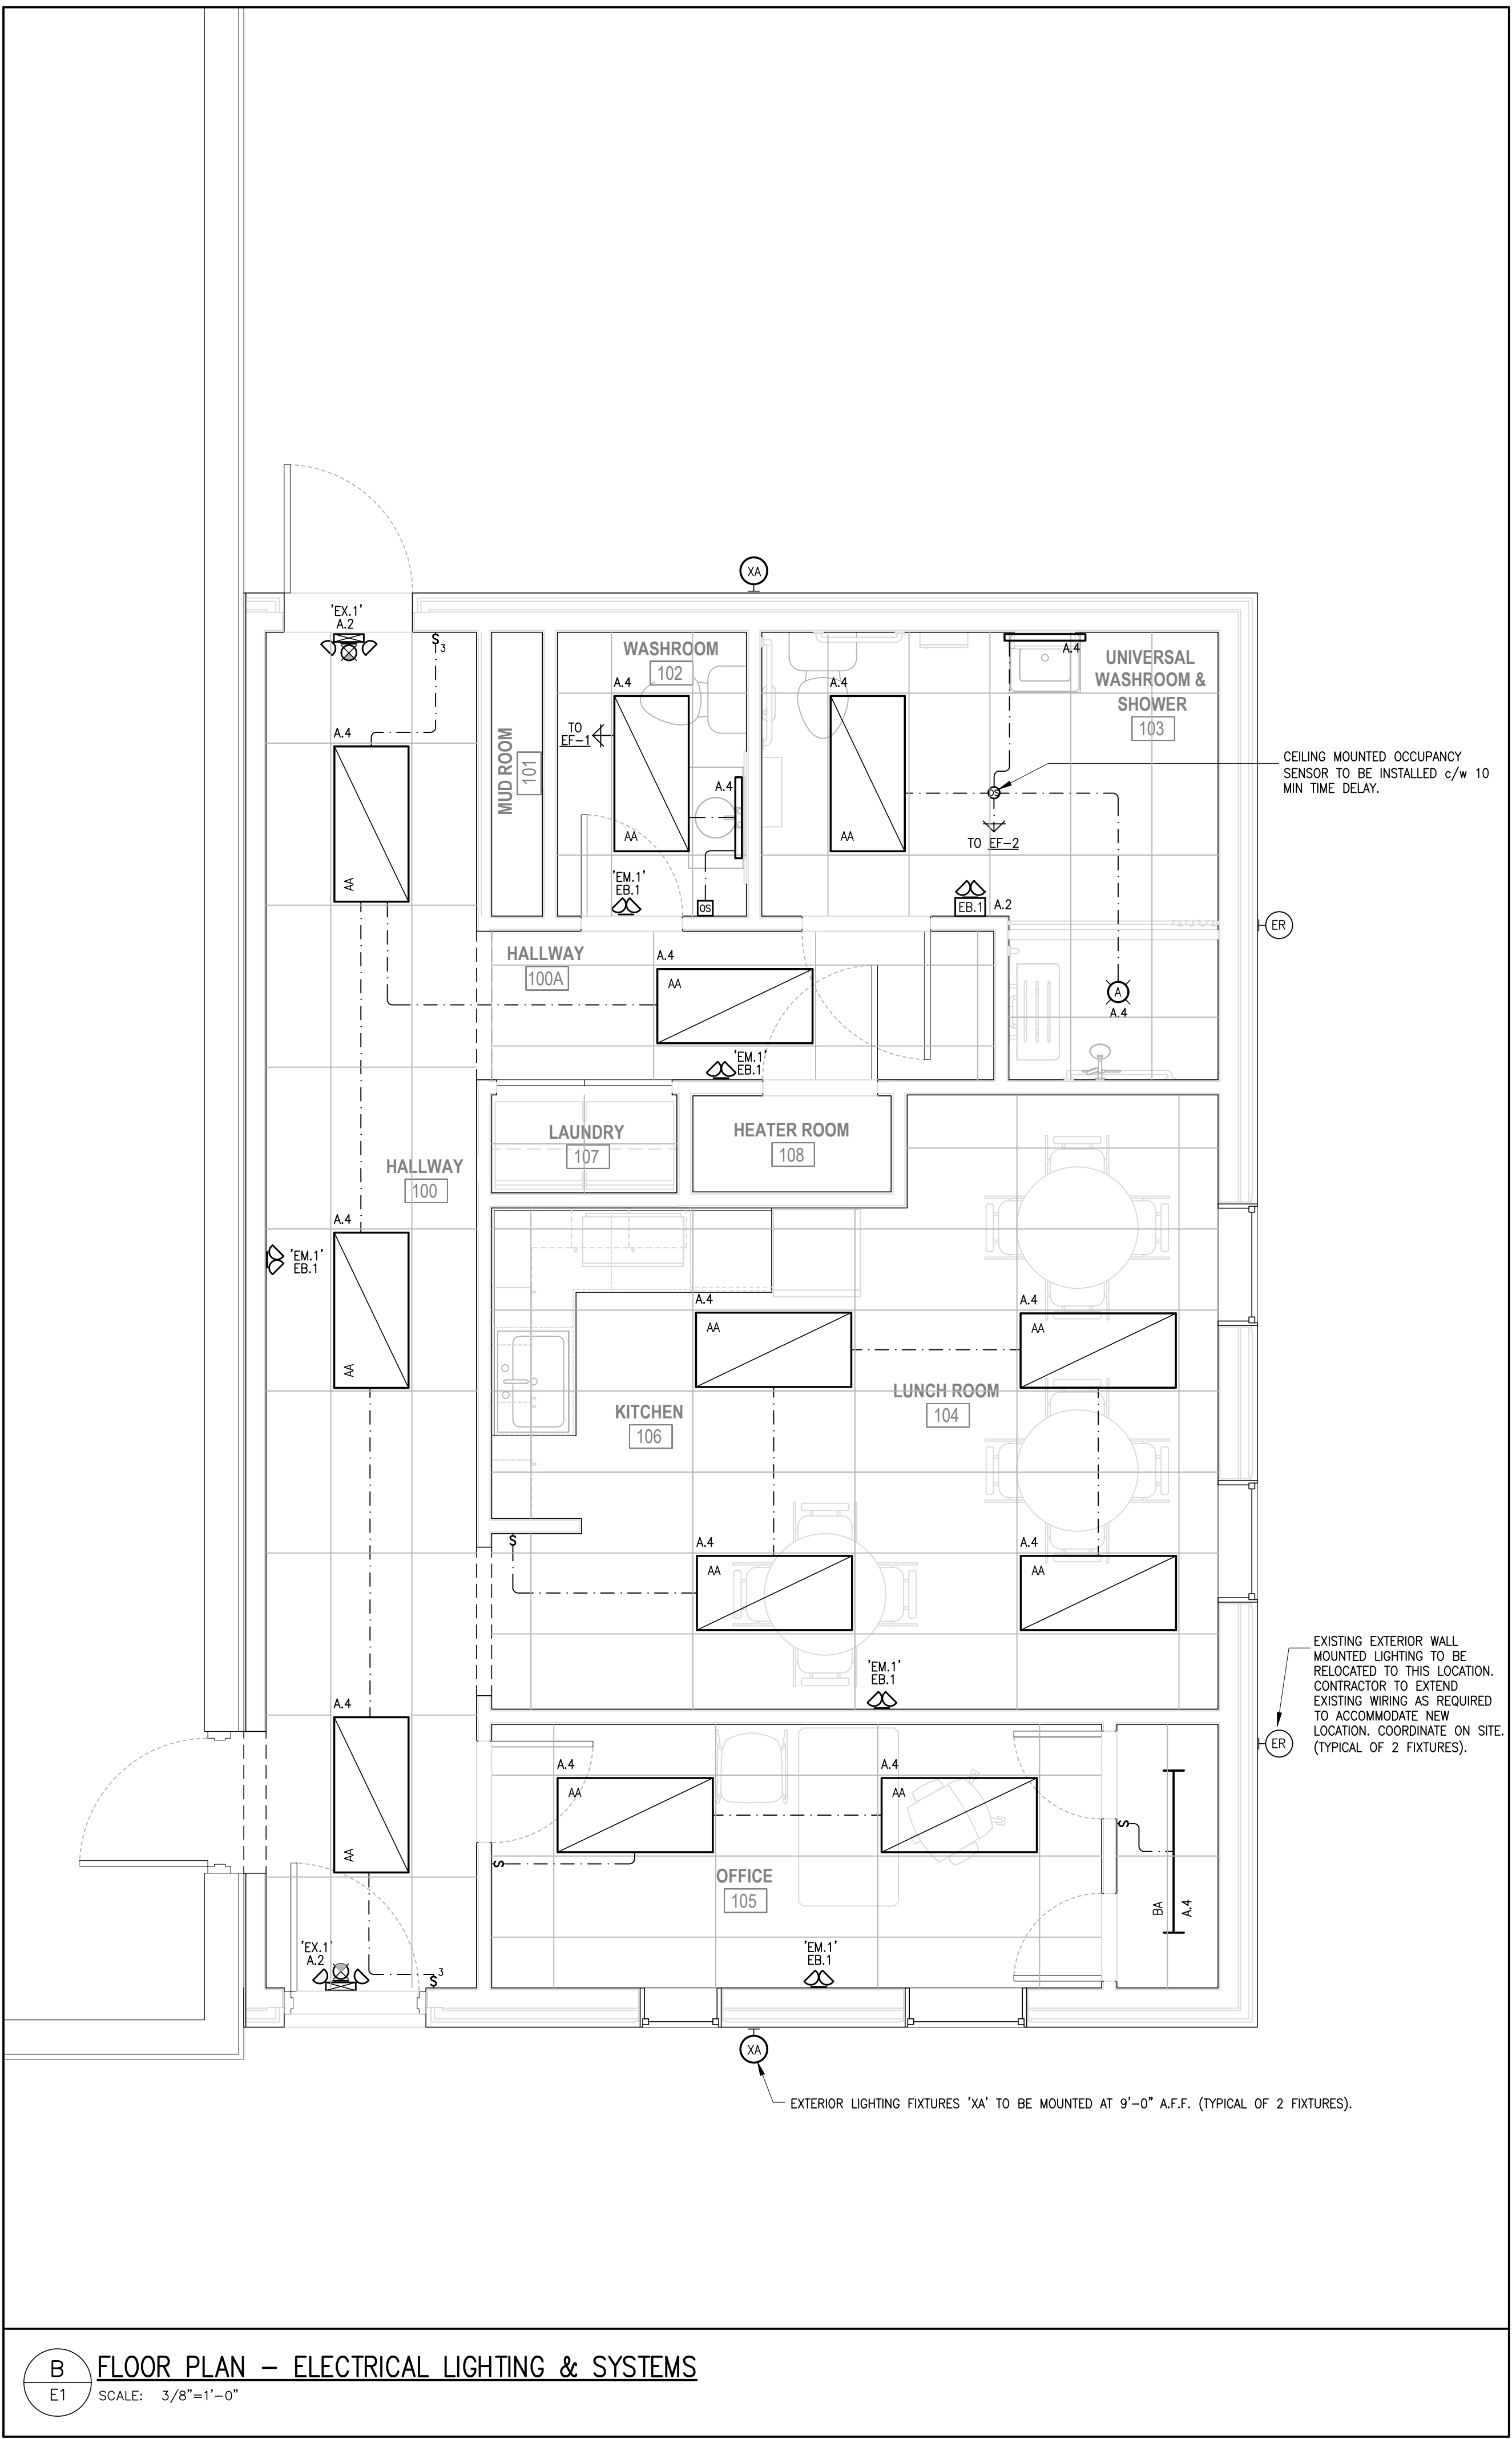


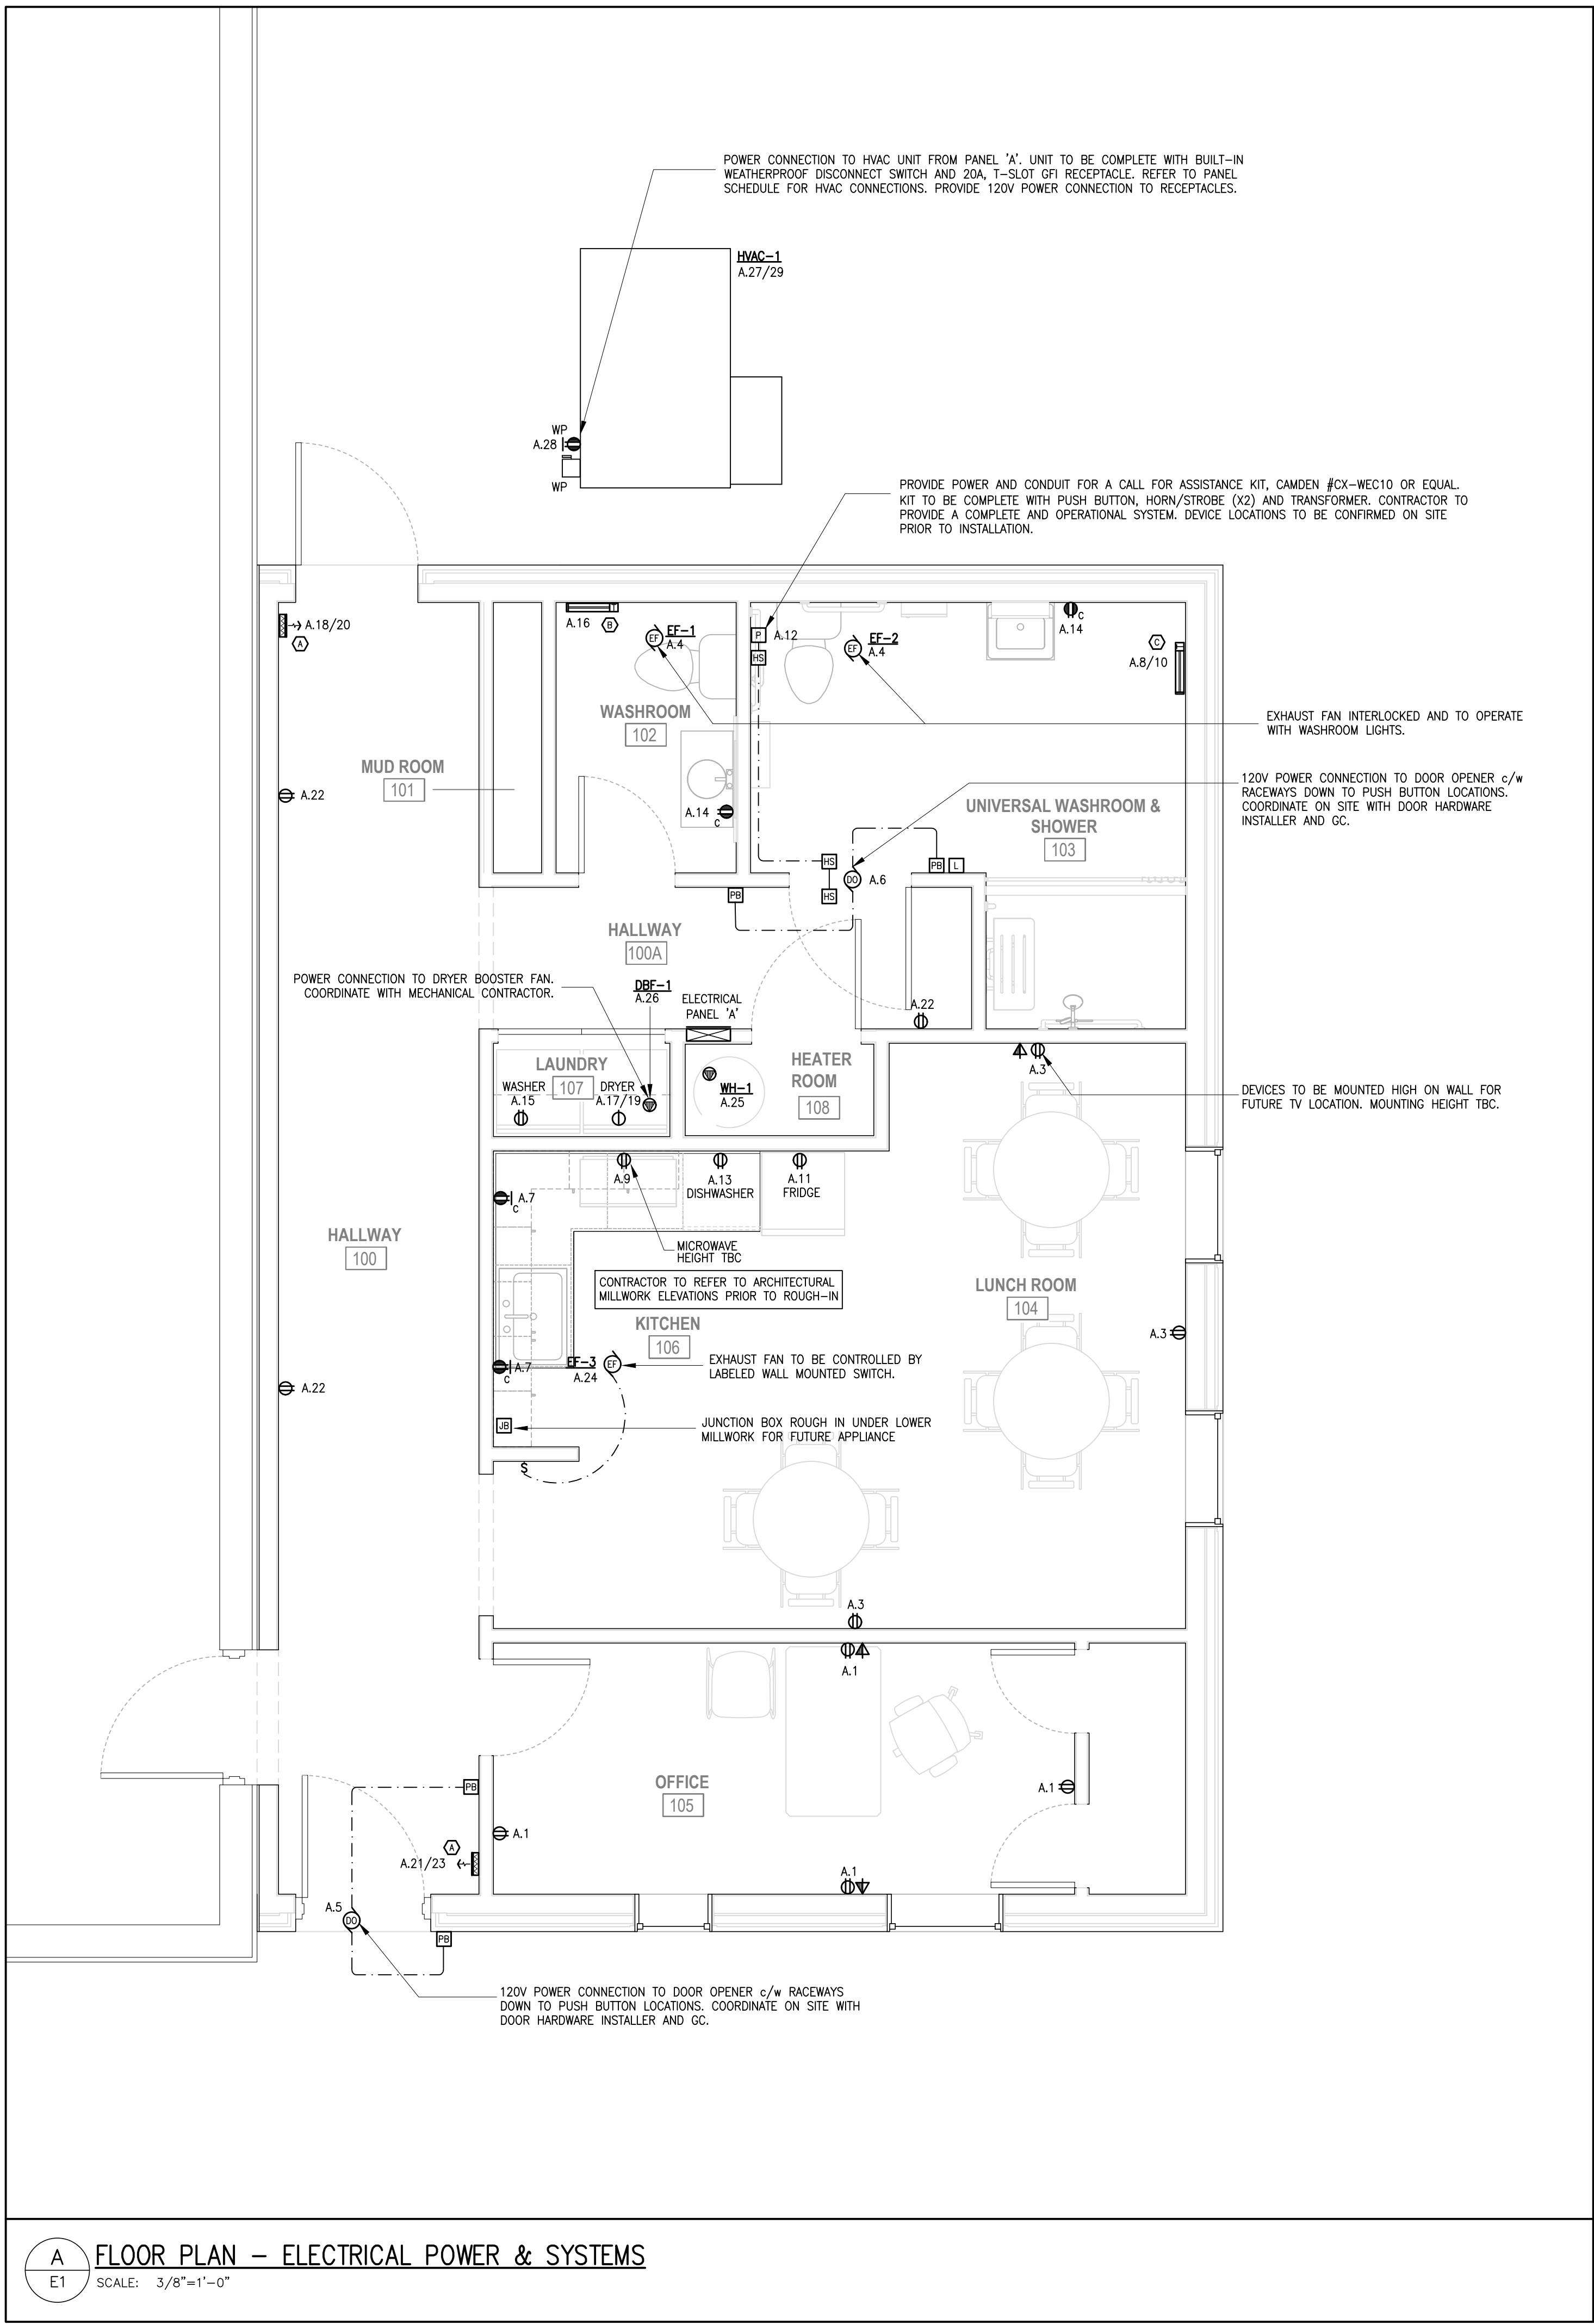



ISSUED FOR PERMIT	26.08.12	
ISSUED FOR PERMIT	26.07.31	
ISSUED FOR REVIEW	26.07.23	
revisions	date	no.

CONTRACTORS MUST CHECK AND VERIFY ALL DIMENSIONS AND REPORT ANY DISCREPANCY TO THIS FIRM BEFORE PROCEEDING WITH THE WORK

A - detail no.
B - location sheet
C - detail sheet

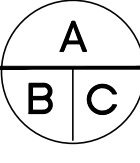

1930 Blue Heron Drive
London, ON N6H 5L9
Tel: 519-472-3688
Fax: 519-472-4322
www.integratedengineering.ca

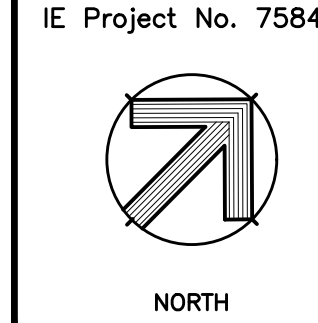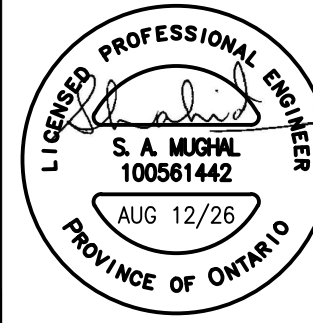

SPRIET
ASSOCIATES



LIMITED
architects
LONDON LTD.
engineers

155 York Street
London ON, N6A 1A8
(519) 672 4100 - mail@spriet.on.ca


GLENCOE PUBLIC
WORKS ADDITION
266 GLENDON DRIVE
GLENCOE, ONTARIO

drawing title :
ELECTRICAL
PLANS

date : JUL. 16, 2026
scale : AS NOTED
drawn by : KG/PO/SAM
project no. : IE 7584

drawing no. :

PANEL	AMPS	VOLTAGE	PHASE	WIRE	CIRCUIT	TYPE	MOUNTING																																																																																																																																																			
A	100	120/240	1	3	42	PANELBOARD	RECESSED																																																																																																																																																			
<table><tr><td>OFFICE RECEPTACLES</td><td>15A</td><td>1</td><td>A</td><td>2</td><td>20A</td><td>EMERGENCY LTG.</td></tr><tr><td>LUNCH RM. RECEPTACLES</td><td>15A</td><td>3</td><td>B</td><td>4</td><td>20A</td><td>LIGHTING</td></tr><tr><td>ENTRY DOOR OPENER</td><td>15A</td><td>5</td><td>C</td><td>6</td><td>15A</td><td>UNIV. WS DOOR OPENER</td></tr><tr><td>COUNTER RECEPTACLES</td><td>20A</td><td>7</td><td>A</td><td>8</td><td>20A</td><td>UNIV. WS BB HEATER</td></tr><tr><td>MICROWAVE RECEPTACLE</td><td>15A</td><td>9</td><td>B</td><td>10</td><td>2P</td><td></td></tr><tr><td>FRIDGE RECEPTACLE</td><td>15A</td><td>11</td><td>C</td><td>12</td><td>15A</td><td>UNIV. WS CALL FOR ASSISTANCE</td></tr><tr><td>DW RECEPTACLE</td><td>15A</td><td>13</td><td>A</td><td>14</td><td>15A</td><td>WS RECEPTACLES</td></tr><tr><td>WASHER</td><td>15A</td><td>15</td><td>B</td><td>16</td><td>15A</td><td>WS BB HEATER</td></tr><tr><td>DRYER</td><td>30A</td><td>17</td><td>C</td><td>18</td><td>20A</td><td>EXIT FF HEATER</td></tr><tr><td></td><td>2P</td><td>19</td><td>A</td><td>20</td><td>2P</td><td></td></tr><tr><td>ENTRY FF HEATER</td><td>20A</td><td>21</td><td>B</td><td>22</td><td>15A</td><td>HALLWAY RECEPTACLES</td></tr><tr><td></td><td>2P</td><td>23</td><td>C</td><td>24</td><td>15A</td><td>EXHAUST FAN [EF-3]</td></tr><tr><td>WATER HEATER</td><td>15A</td><td>25</td><td>A</td><td>26</td><td>15A</td><td>DRYER BOOSTER FAN [DBF-1]</td></tr><tr><td>HVAC-1</td><td>30A</td><td>27</td><td>B</td><td>28</td><td>20A</td><td>HVAC RECEPTACLE</td></tr><tr><td></td><td>2P</td><td>29</td><td>C</td><td>30</td><td></td><td></td></tr><tr><td></td><td></td><td>31</td><td>A</td><td>32</td><td></td><td></td></tr><tr><td></td><td></td><td>33</td><td>B</td><td>34</td><td></td><td></td></tr><tr><td></td><td></td><td>35</td><td>C</td><td>36</td><td></td><td></td></tr><tr><td></td><td></td><td>37</td><td>A</td><td>38</td><td></td><td></td></tr><tr><td></td><td></td><td>39</td><td>B</td><td>40</td><td></td><td></td></tr><tr><td></td><td></td><td>41</td><td>C</td><td>42</td><td></td><td></td></tr></table>								OFFICE RECEPTACLES	15A	1	A	2	20A	EMERGENCY LTG.	LUNCH RM. RECEPTACLES	15A	3	B	4	20A	LIGHTING	ENTRY DOOR OPENER	15A	5	C	6	15A	UNIV. WS DOOR OPENER	COUNTER RECEPTACLES	20A	7	A	8	20A	UNIV. WS BB HEATER	MICROWAVE RECEPTACLE	15A	9	B	10	2P		FRIDGE RECEPTACLE	15A	11	C	12	15A	UNIV. WS CALL FOR ASSISTANCE	DW RECEPTACLE	15A	13	A	14	15A	WS RECEPTACLES	WASHER	15A	15	B	16	15A	WS BB HEATER	DRYER	30A	17	C	18	20A	EXIT FF HEATER		2P	19	A	20	2P		ENTRY FF HEATER	20A	21	B	22	15A	HALLWAY RECEPTACLES		2P	23	C	24	15A	EXHAUST FAN [EF-3]	WATER HEATER	15A	25	A	26	15A	DRYER BOOSTER FAN [DBF-1]	HVAC-1	30A	27	B	28	20A	HVAC RECEPTACLE		2P	29	C	30					31	A	32					33	B	34					35	C	36					37	A	38					39	B	40					41	C	42		
OFFICE RECEPTACLES	15A	1	A	2	20A	EMERGENCY LTG.																																																																																																																																																				
LUNCH RM. RECEPTACLES	15A	3	B	4	20A	LIGHTING																																																																																																																																																				
ENTRY DOOR OPENER	15A	5	C	6	15A	UNIV. WS DOOR OPENER																																																																																																																																																				
COUNTER RECEPTACLES	20A	7	A	8	20A	UNIV. WS BB HEATER																																																																																																																																																				
MICROWAVE RECEPTACLE	15A	9	B	10	2P																																																																																																																																																					
FRIDGE RECEPTACLE	15A	11	C	12	15A	UNIV. WS CALL FOR ASSISTANCE																																																																																																																																																				
DW RECEPTACLE	15A	13	A	14	15A	WS RECEPTACLES																																																																																																																																																				
WASHER	15A	15	B	16	15A	WS BB HEATER																																																																																																																																																				
DRYER	30A	17	C	18	20A	EXIT FF HEATER																																																																																																																																																				
	2P	19	A	20	2P																																																																																																																																																					
ENTRY FF HEATER	20A	21	B	22	15A	HALLWAY RECEPTACLES																																																																																																																																																				
	2P	23	C	24	15A	EXHAUST FAN [EF-3]																																																																																																																																																				
WATER HEATER	15A	25	A	26	15A	DRYER BOOSTER FAN [DBF-1]																																																																																																																																																				
HVAC-1	30A	27	B	28	20A	HVAC RECEPTACLE																																																																																																																																																				
	2P	29	C	30																																																																																																																																																						
		31	A	32																																																																																																																																																						
		33	B	34																																																																																																																																																						
		35	C	36																																																																																																																																																						
		37	A	38																																																																																																																																																						
		39	B	40																																																																																																																																																						
		41	C	42																																																																																																																																																						
NOTE 1 - CONFIRM POWER REQUIREMENTS PRIOR TO ROUGH-IN. ** - DENOTES A LOCK ON BREAKER *** - DENOTES TO BE CONTROLLED BY CONTACTOR																																																																																																																																																										
A PANEL SCHEDULE																																																																																																																																																										

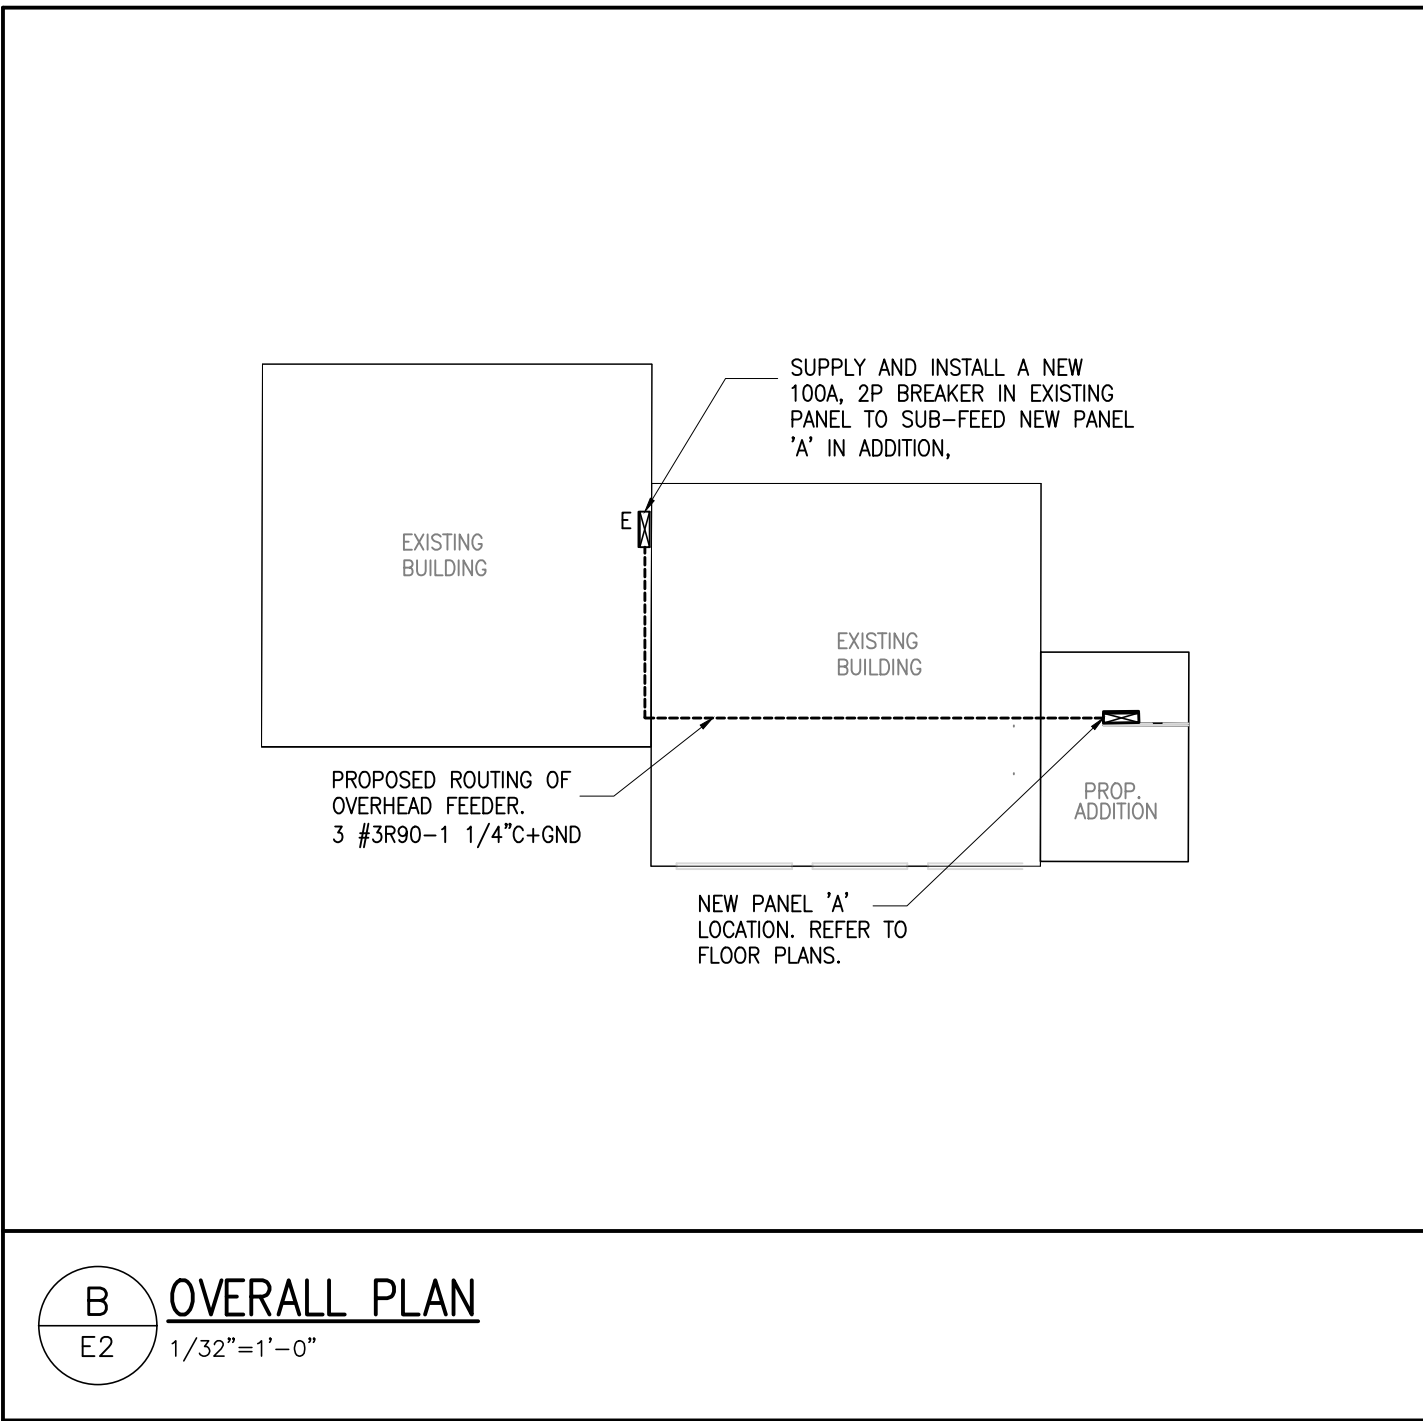

TYPE	DESCRIPTION	LAMPS [QTY]	REMARKS	VOLT.
INTERIOR LIGHTING FIXTURES				
AA	2' X 4' LED RECESSED FLAT PANEL. SWITCHABLE LUMENS AND COLOR TEMPERATURE.	LED 29.5W SWITCHABLE CCT SWITCHABLE LUMENS	LITHONIA LIGHTING: CPX 2X4 AL08 80CRI SSW7	120V
A	4" LED ROUND DOWNLIGHT. ADJUSTABLE LUMEN OUTPUT, SWITCHABLE COLOR TEMPERATURE. TRIM COLOR TO BE CONFIRMED. RATED FOR WET LOCATION.	LED 25W SWITCHABLE CCT 1000/1500/2000 LUMENS	LITHONIA LIGHTING: AL02 SSW1 L04 MW MVOLT	120V
CA	4'-0" LED SUSPENDED/WALL MOUNTED INDUSTRIAL STRIP FIXTURE.	LED 38W 4000K CCT 4333 LUMENS	LITHONIA LIGHTING: CSS L48 4000LM MVOLT 40K 80CRI	120V
CB	2'-0" WALL MOUNTED LED VANITY LIGHT c/w SATIN ICE ACRYLIC (LAY-IN).	LED 14W 4000K CCT 1442 LUMENS	DAY-O-LITE: PRFL 44 D SI 40 SO 2 S W	120V
EXTERIOR LIGHTING FIXTURES				
ER	EXISTING LIGHT FIXTURE TO BE REUSED AND RELOCATED.	--	--	--
XA	EXTERIOR WALL PACK MOUNTED AT 9'-0" A.F.G. TYPE II MEDIUM DISTRIBUTION.	LED 12.4W 3500K CCT 2000 LUMENS	LITHONIA LIGHTING: DSXW1 LED P1 35K 70CRI T2M	120V
FIXTURES ARE LISTED FOR REFERENCE ONLY. ALTERNATE LIGHTING FIXTURES MAY BE SUPPLIED WITH OWNER'S APPROVAL.				
C LIGHTING FIXTURE SCHEDULE				

TYPE	DESCRIPTION	MANUFACTURER	CATALOGUE NO.	VAC	VDC
EB.1	EMERGENCY BATTERY UNIT c/w HEADS	STANPRO	SLA-2L	120	12
EM.1	WALL MOUNTED REMOTE EMERGENCY DOUBLE HEAD	STANPRO	N2-12-12V7WLAWH	120	12
EX.1	COMBO EXIT SIGN c/w EMERGENCY LTG.	STANPRO	PRMS-2L	120	12
FIXTURES ARE LISTED FOR REFERENCE ONLY. ALTERNATE EMERGENCY/EXIT LIGHTING FIXTURES MAY BE SUPPLIED WITH OWNER'S APPROVAL.					
D EMERGENCY LIGHTING SCHEDULE					

TYPE	DESCRIPTION	MOUNTING	VOLTAGE	MANUFACTURER	CATALOGUE NO.
☒	WALL SWITCH VACANCY SENSOR	WALL	120V	SENSORSWITCH	WSX PDT SA
☑	CEILING MOUNTED OCCUPANCY SENSOR c/w TIME DELAY	CEILING	120V	SENSORSWITCH	CM PDT 2P
LIGHTING CONTROL NOTES: 1. COORDINATE ON SITE THE SENSITIVITY AND SENSING PARAMETERS OF MOTION DETECTORS					
E OCCUPANCY SENSOR SCHEDULE					

TYPE	DESCRIPTION	MOUNTING	CATALOGUE NO.	WATTS	VOLTAGE	REMARKS
⬠	FORCE FLOW HEATER	WALL	OUELLET: OACO1502-T	1500W	120V/1ø	WALL MOUNTED BRACKET c/w 24V RELAY & TRANSFORMER (KIT-OAS-RT)
⬡	BASEBOARD HEATER	WALL	STELPRO: B0501W	500W	120V/1ø	SURFACE MOUNTED FAN FORCED HEATER c/w BUILT IN THERMOSTAT
⬢	BASEBOARD HEATER	WALL	STELPRO: B1501W	1500W	120V/1ø	SURFACE MOUNTED FAN FORCED HEATER c/w BUILT IN THERMOSTAT
HEATERS ARE LISTED FOR REFERENCE ONLY. ALTERNATE ELECTRIC HEATERS MAY BE SUPPLIED WITH OWNER'S APPROVAL.						
F ELECTRIC HEATING SCHEDULE						

ISSUED FOR PERMIT

26.08.12

ISSUED FOR PERMIT

26.07.31

ISSUED FOR REVIEW

26.07.23

revisions

date

no.

CONTRACTORS MUST CHECK AND VERIFY ALL DIMENSIONS AND REPORT ANY DISCREPANCY TO THIS FIRM BEFORE PROCEEDING WITH THE WORK

A - detail no.

B - location sheet

C - detail sheet

A

B

C

1930 Blue Heron Drive
London, ON N6H 5L9
Tel: 519-472-3688
Fax: 519-472-4322
www.integratedengineering.ca

IE Project No. 7584

NORTH

SPRIET ASSOCIATES

LIMITED
architects
LONDON LTD.
engineers

155 York Street
London ON, N6A 1A8
(519) 672 4100 - mail@spriet.on.ca

GLENCOE PUBLIC WORKS ADDITION

266 GLENDON DRIVE
GLENCOE, ONTARIO

drawing title :
ELECTRICAL PLANS

date : JUL. 16, 2026

scale : AS NOTED

drawn by : KG/PO/SAM

project no. : IE 7584

drawing no. :

